



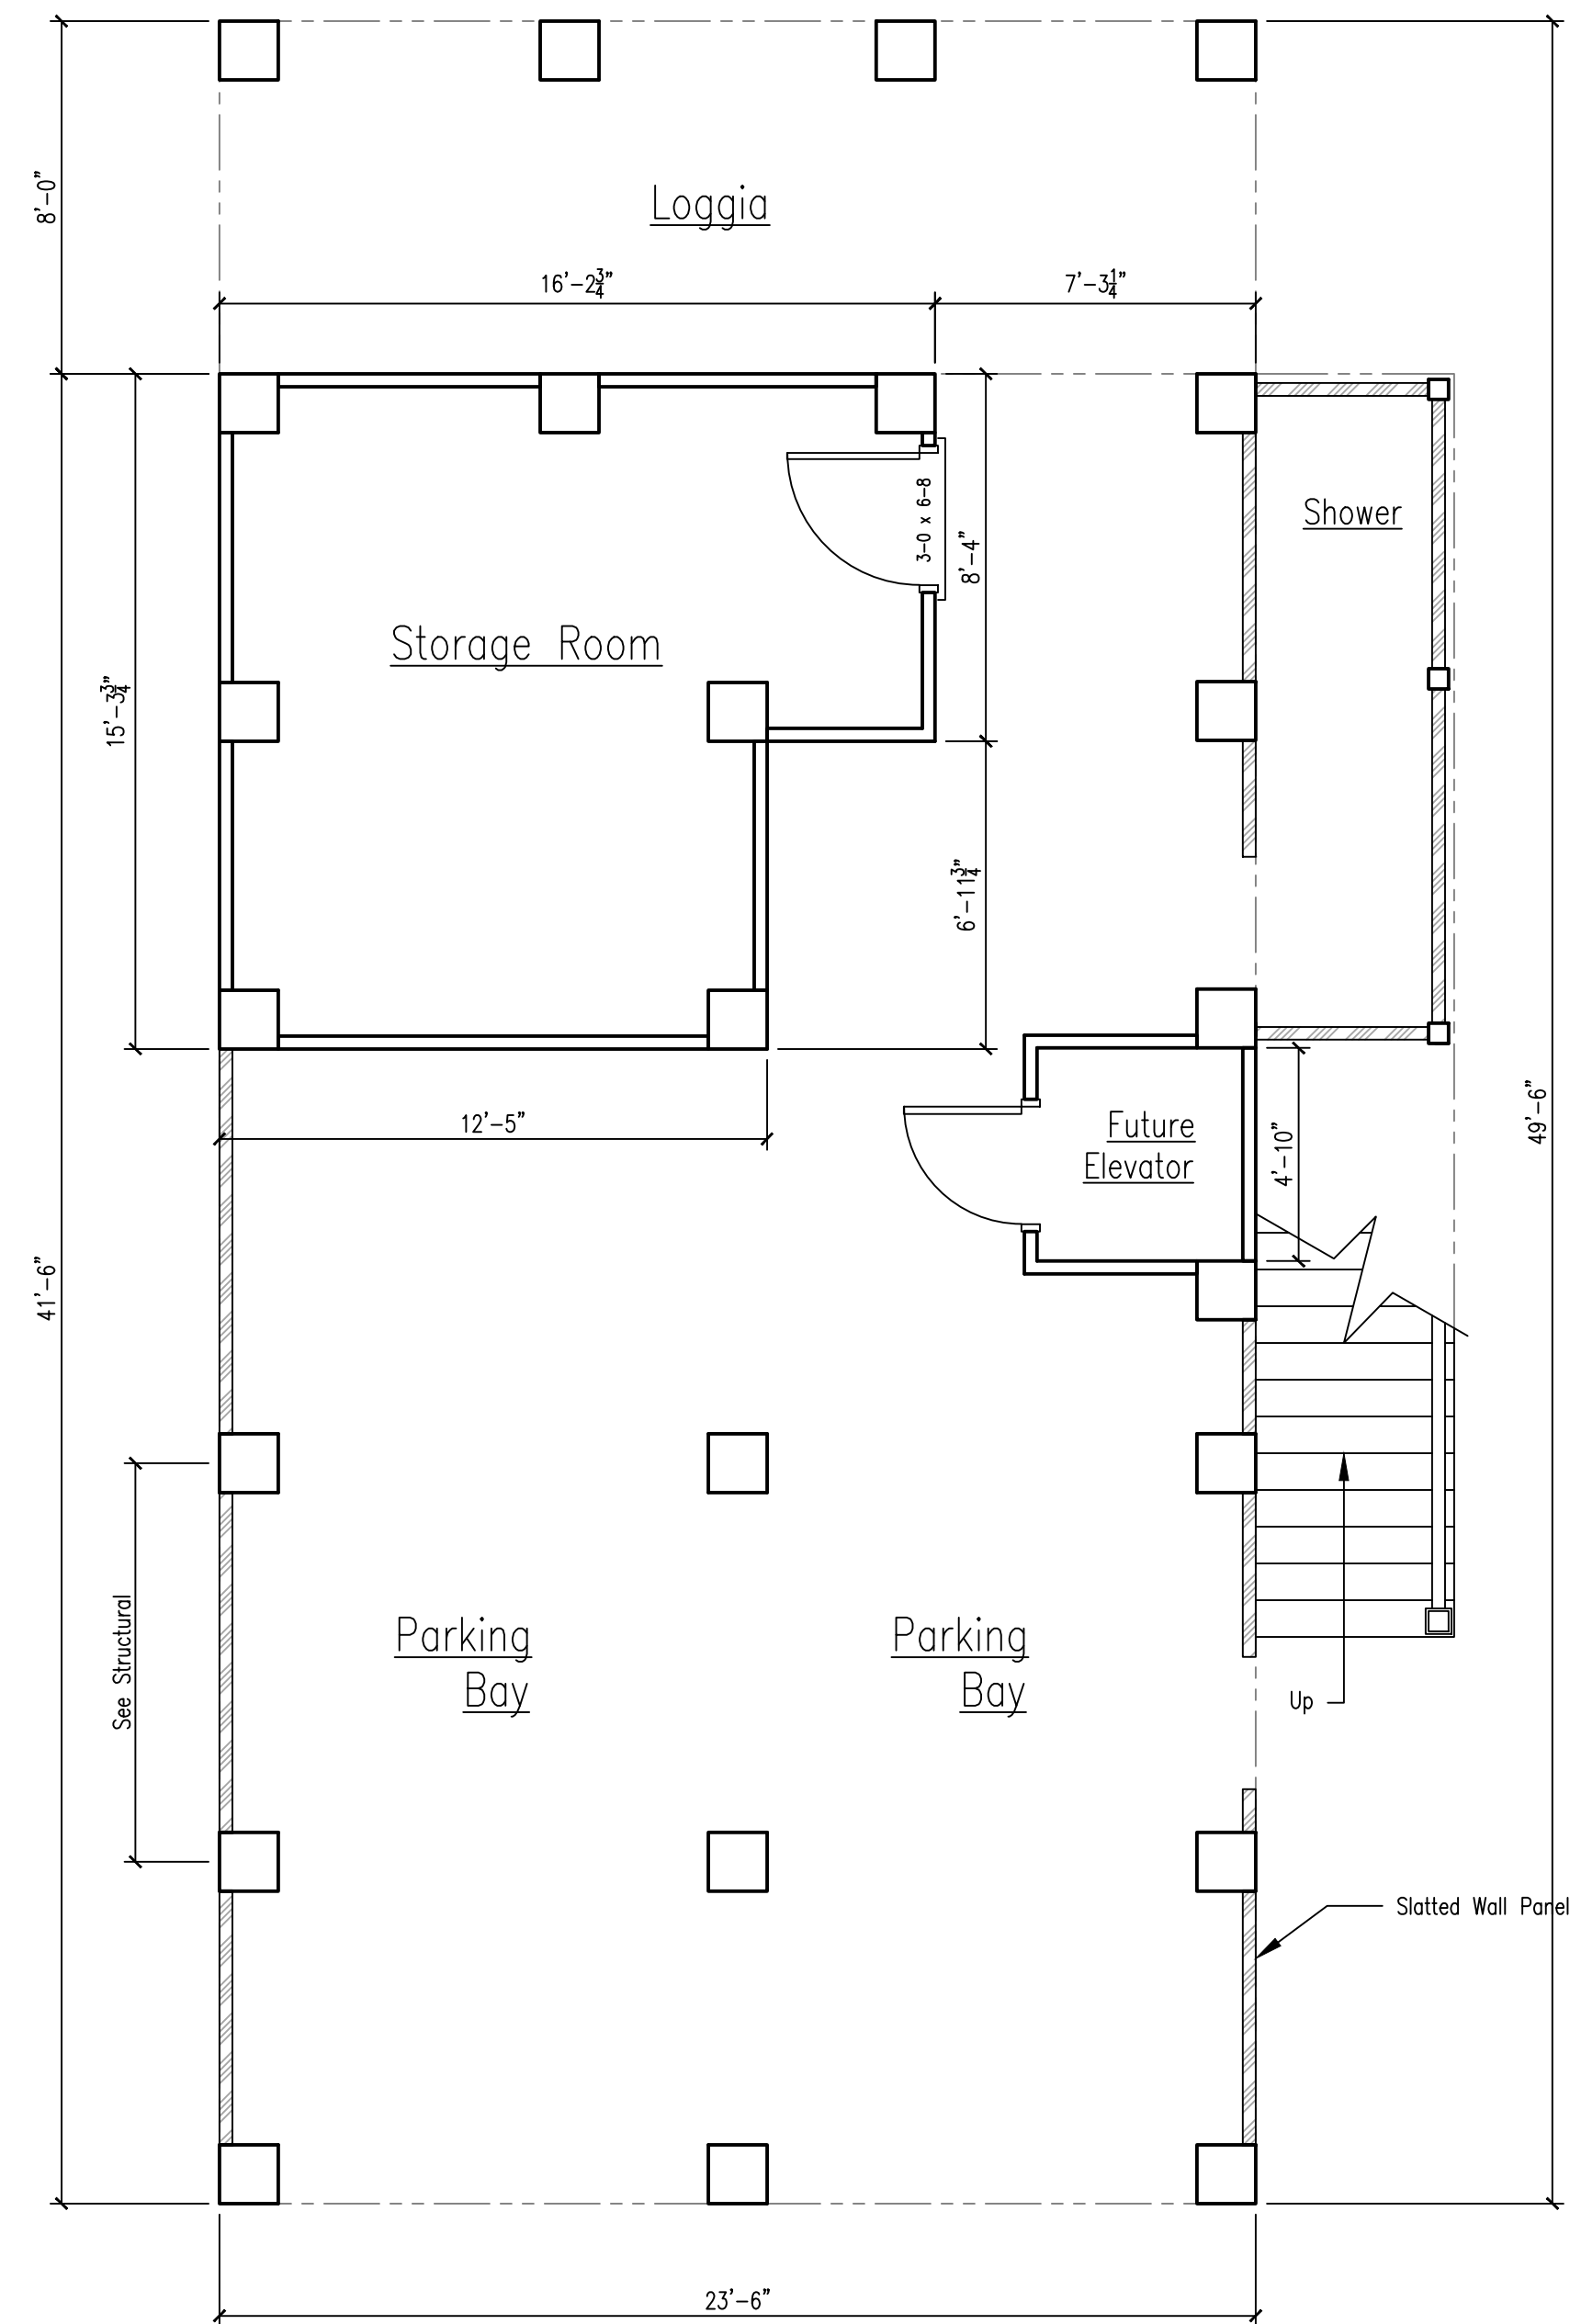

Ground Floor Plan

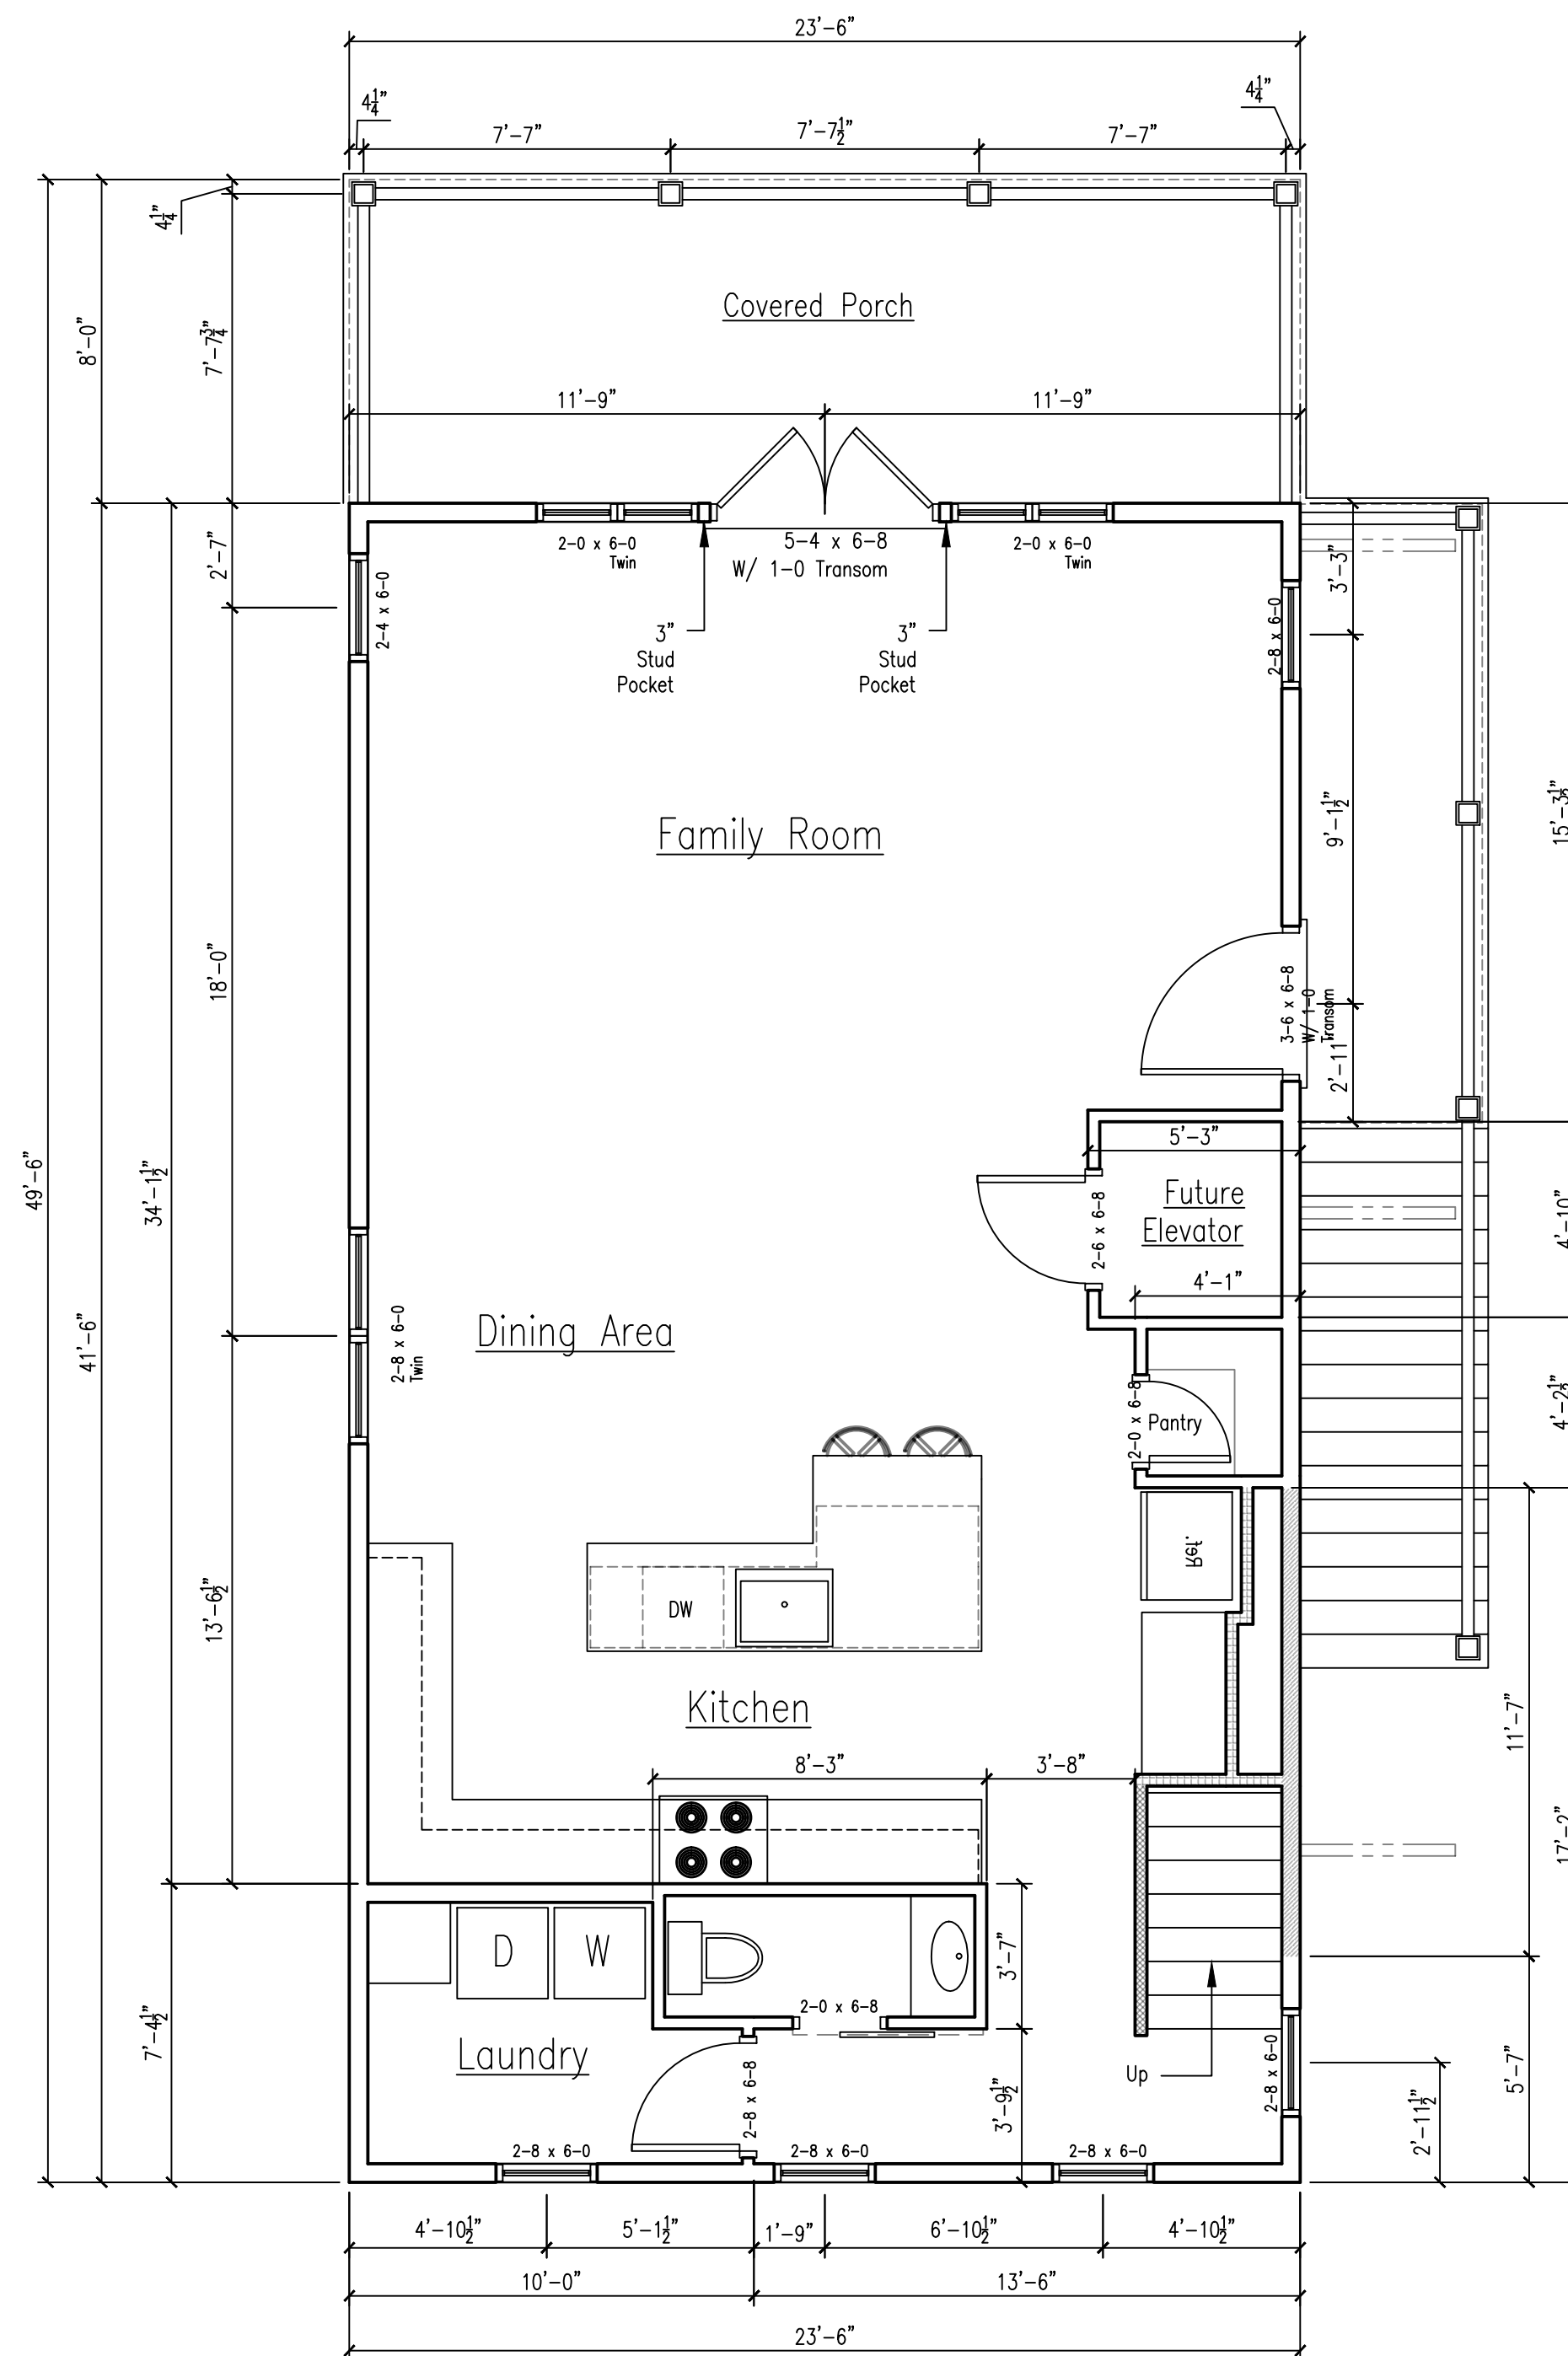

Main Floor Plan

Legend	
	2 Story Balloon Framing
	Balloon Frame Under Stairs
	Slotted Wall Panel
Area	
Main Floor Heated	975
Second Floor Heated	1,163
Total Heated Area	2,138
Covered Porch	188
Elevator/Storage	250
Covered Parking/ Loggia	913
Total Under Roof	3,489

CHAMBLISS RESIDENCE
LOT 31 MARSHLAND PARK
GEORGETOWN COUNTY, SC

DESIGNS
BY
DANIEL


1700 Highway 101, Suite 101
Milledgeville, GA 30651
Phone: (706) 222-2255

PROJECT REF.
Lot 31 MP


DRAWING STATUS/ DATE
☒ Estimating 8-14-18
☒ Construction 1-28-19

DRAWING
Ground Floor Plan
Main Floor Plan
Scale: 1/4" = 1'-0"

Page #
1

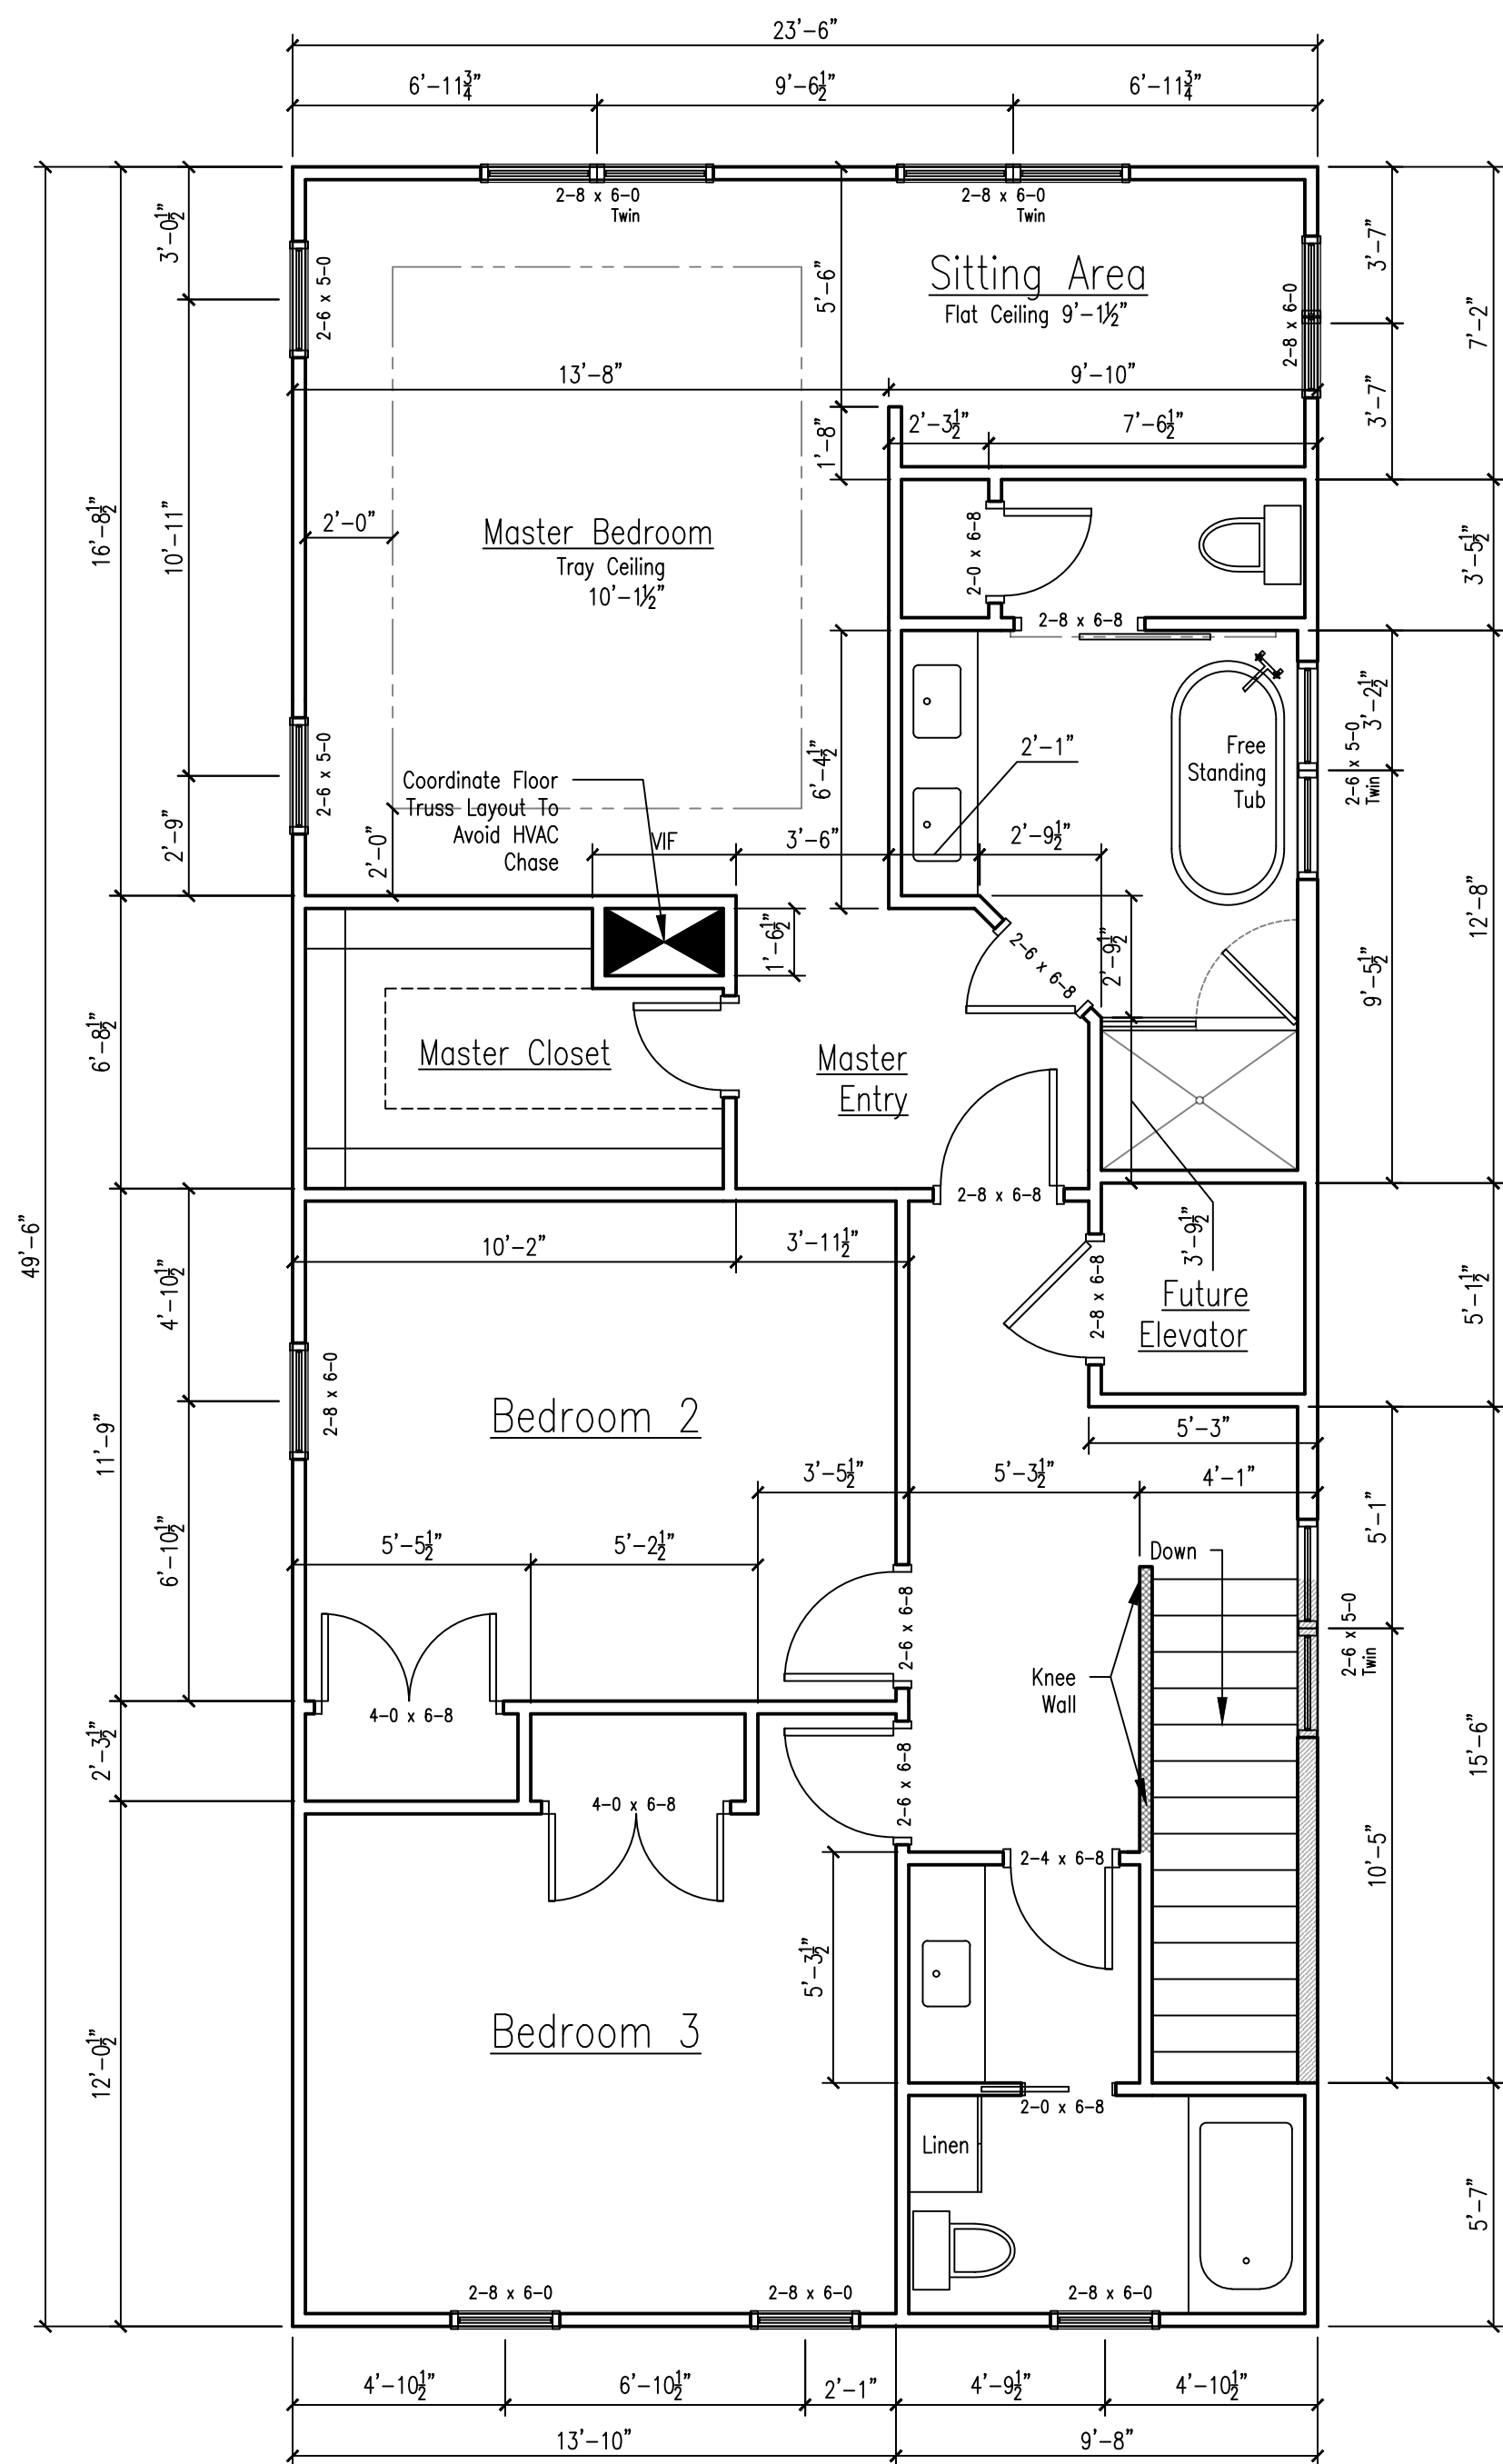

Upper Floor Plan

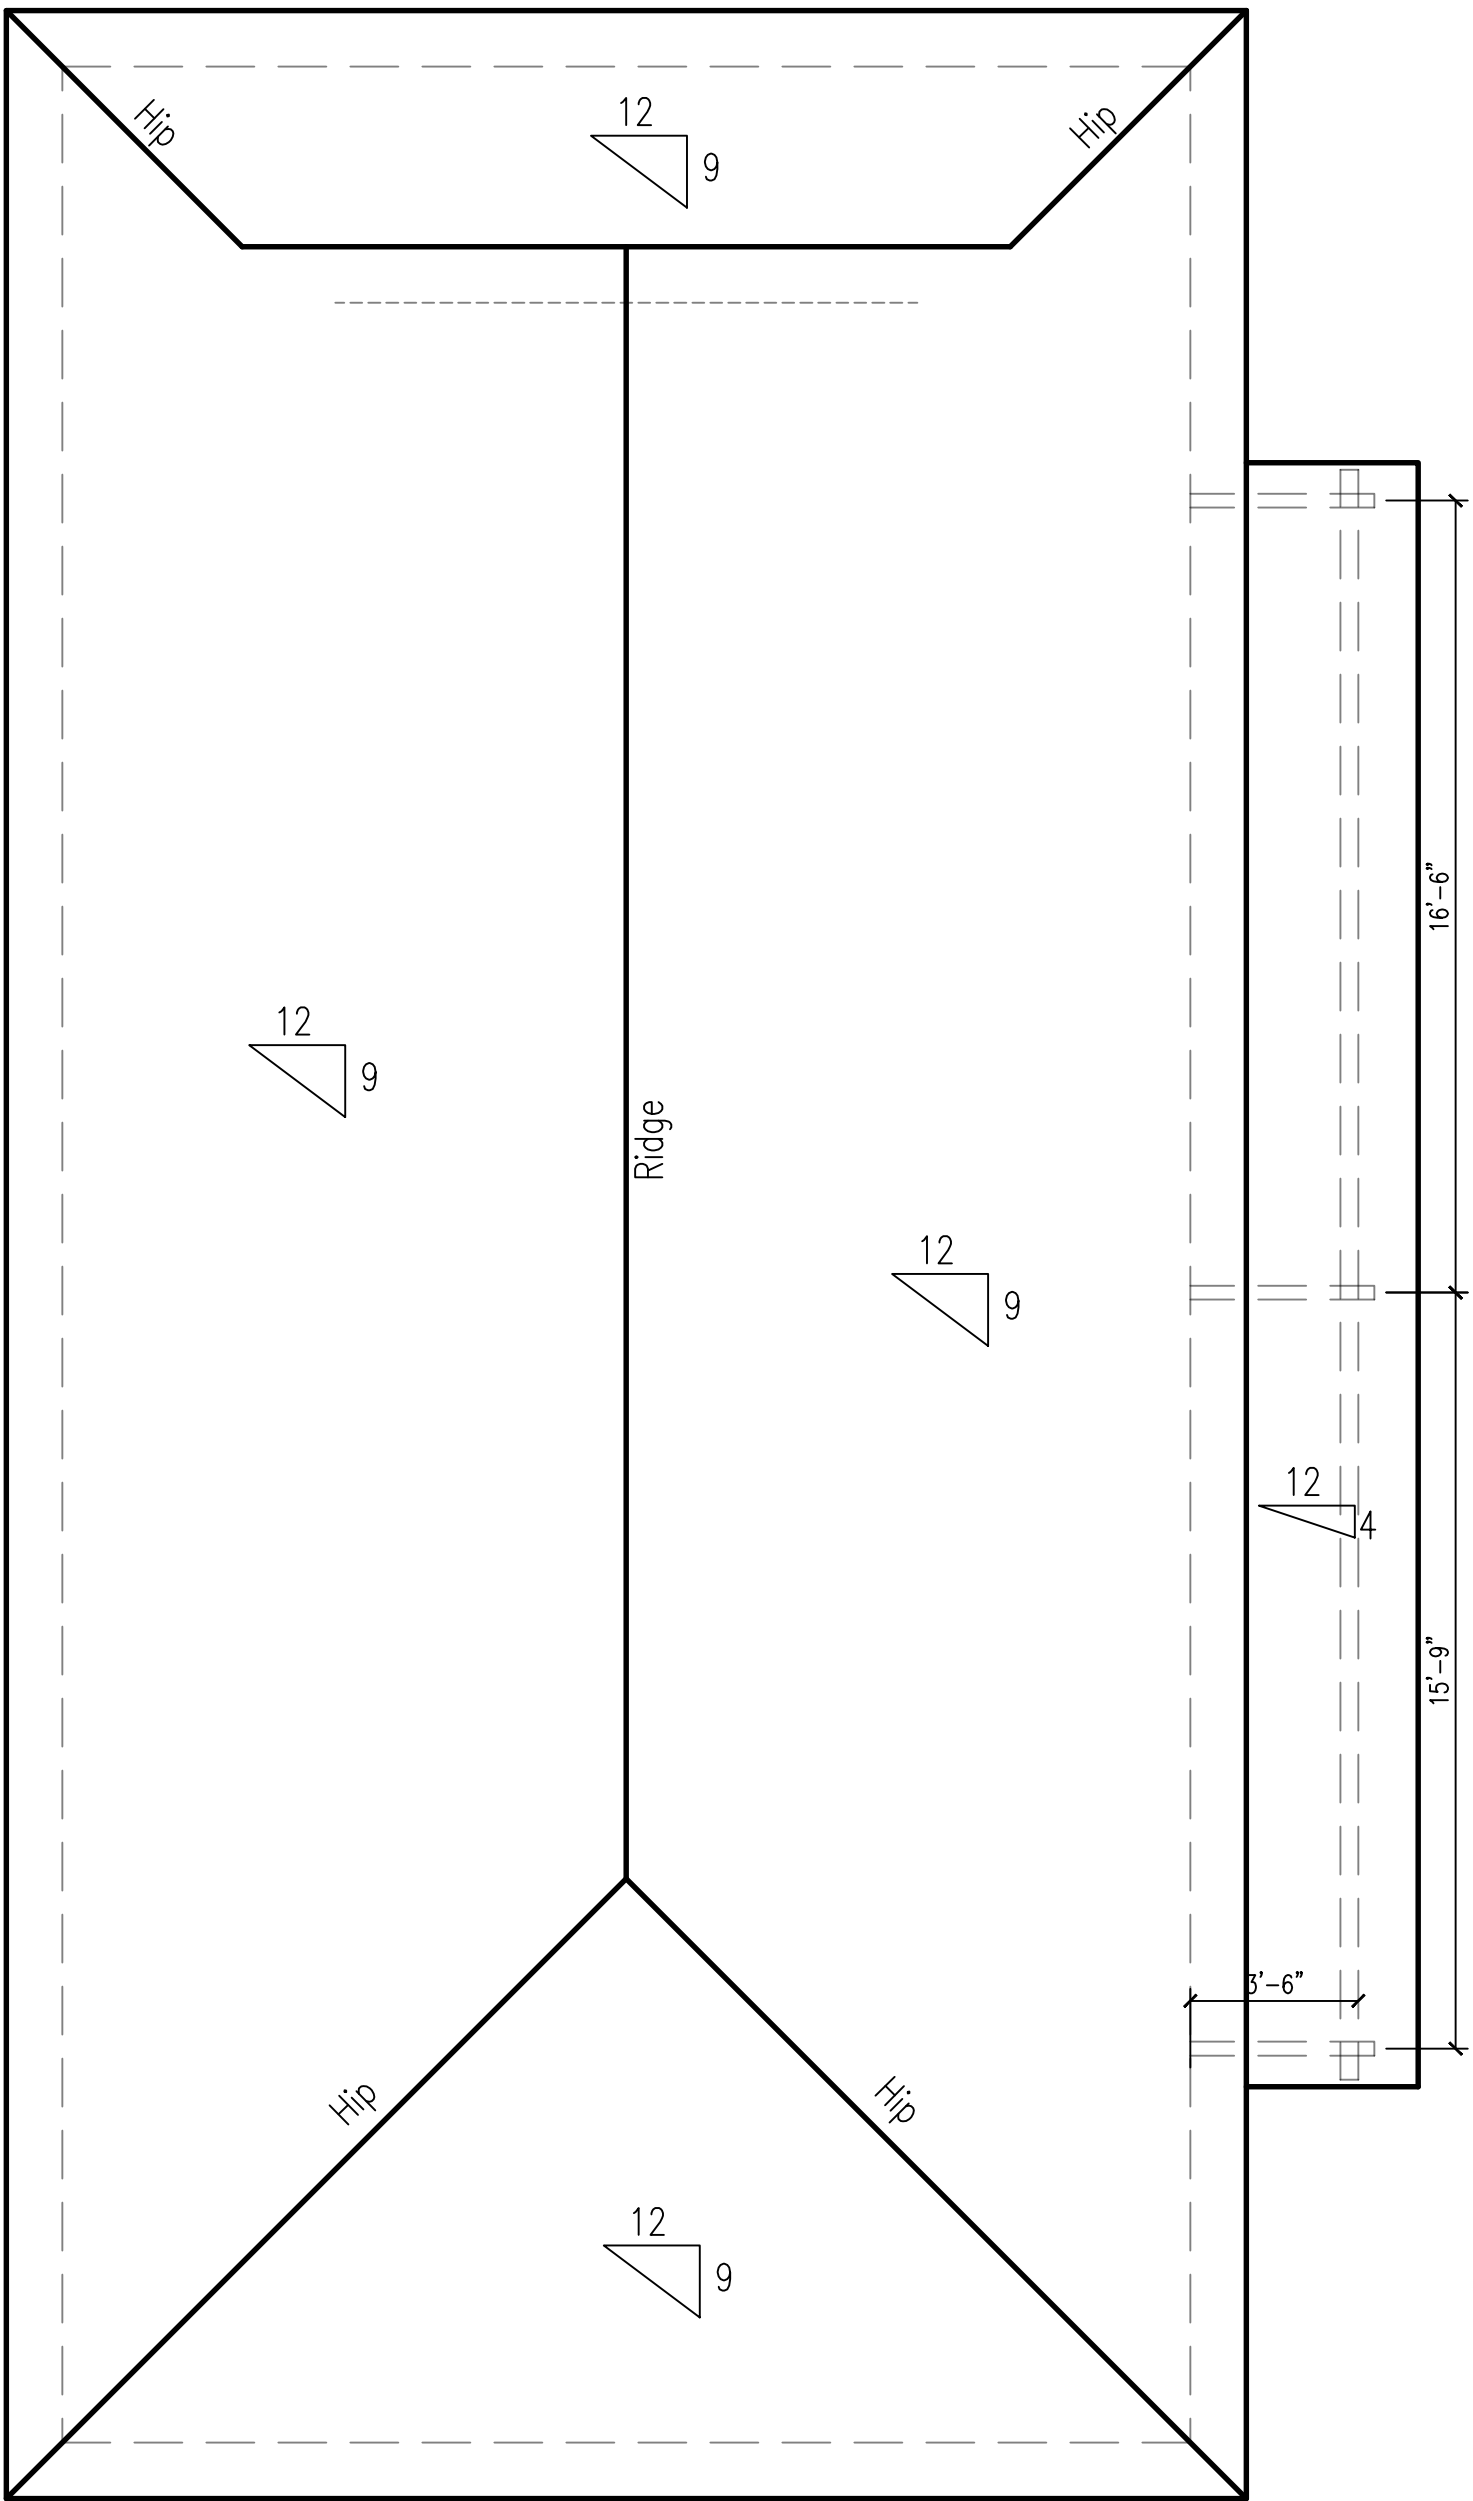

Roof Plan

Legend	
	2 Story Balloon Framing
	Balloon Frame Under Stairs
	Slatted Wall Panel
Area	
Main Floor Heated	975
Second Floor Heated	1,163
Total Heated Area	2,138
Covered Porch	188
Elevator/Storage	250
Covered Parking/ Loggia	913
Total Under Roof	3,489

CHAMBLISS RESIDENCE
LOT 31 MARSHLAND PARK
GEORGETOWN COUNTY, SC

DESIGNS
BY
DANIEL


1700 PLYMOUTH ROAD, BLDG. 100
MYRTLE BEACH, SC 29577-2255
(843) 222-2255

PROJECT REF.
Lot 31 MP

DRAWING STATUS/ DATE
☒ Estimating 8-14-18
☒ Construction 1-28-19

DRAWING
Upper Floor Plan
Roof Plan
Scale: 1/4" = 1'-0"

Page #
2

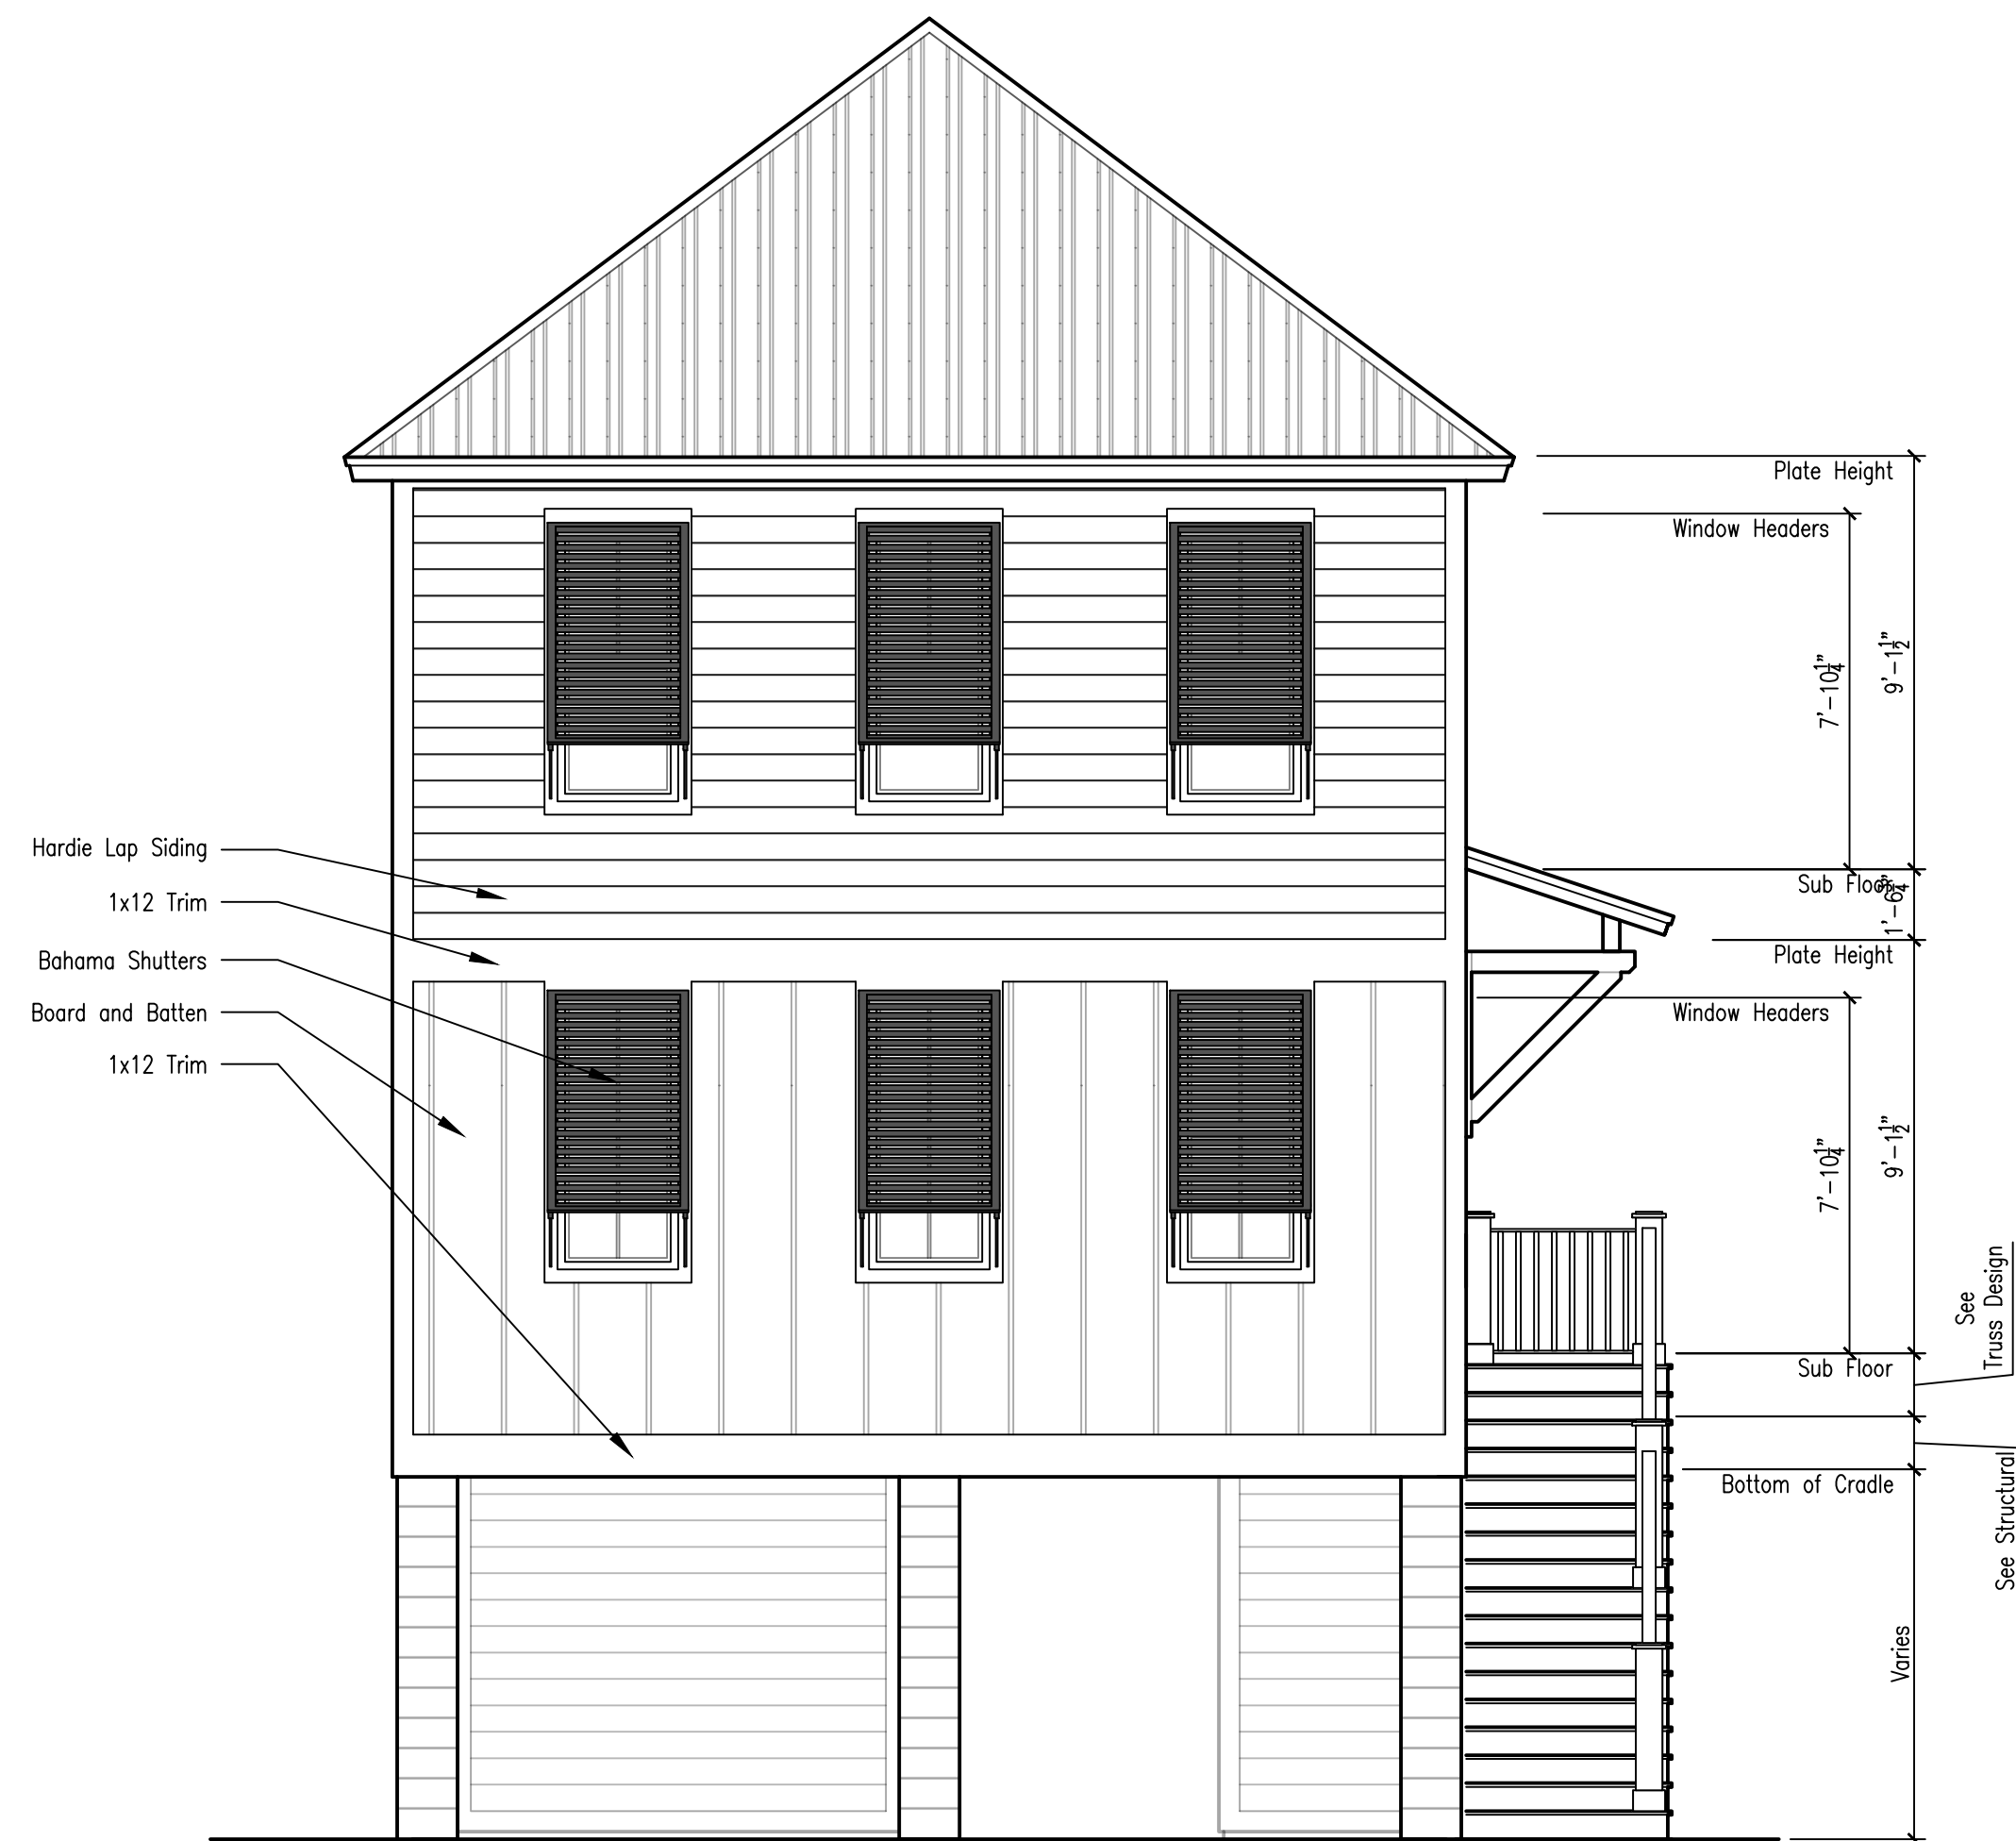

Front Elevation



Right Elevation

CHAMBLISS RESIDENCE
LOT 31 MARSHLAND PARK
GEORGETOWN COUNTY, SC

DESIGNS
BY
DANIEL

1700 Highway 17, Suite 104
Myrtle Beach, SC 29577-2255

PROJECT REF.
Lot 31 MP

DRAWING STATUS/ DATE

☒ Estimating 8-14-18
☒ Construction 1-28-19

DRAWING
Front and Left
Elevations

Scale: 1/4" = 1'-0"

Page #

3



Rear Elevation

Left Elevation



PROJECT REF.
Lot 31 MP

DRAWING STATUS/ DATE
☒ Estimating 8-14-18
☒ Construction 1-28-19

DRAWING
Rear and Right
Elevations


Scale: 1/4" = 1'-0"

Page #


4

CHAMBLISS RESIDENCE
LOT 31 MARSHLAND PARK
GEORGETOWN COUNTY, SC


DESIGNS
BY
DANIEL
1000 PINEHURST ROAD, SUITE 100
MYRTLE BEACH, SC 29577-2255
(843) 222-2255

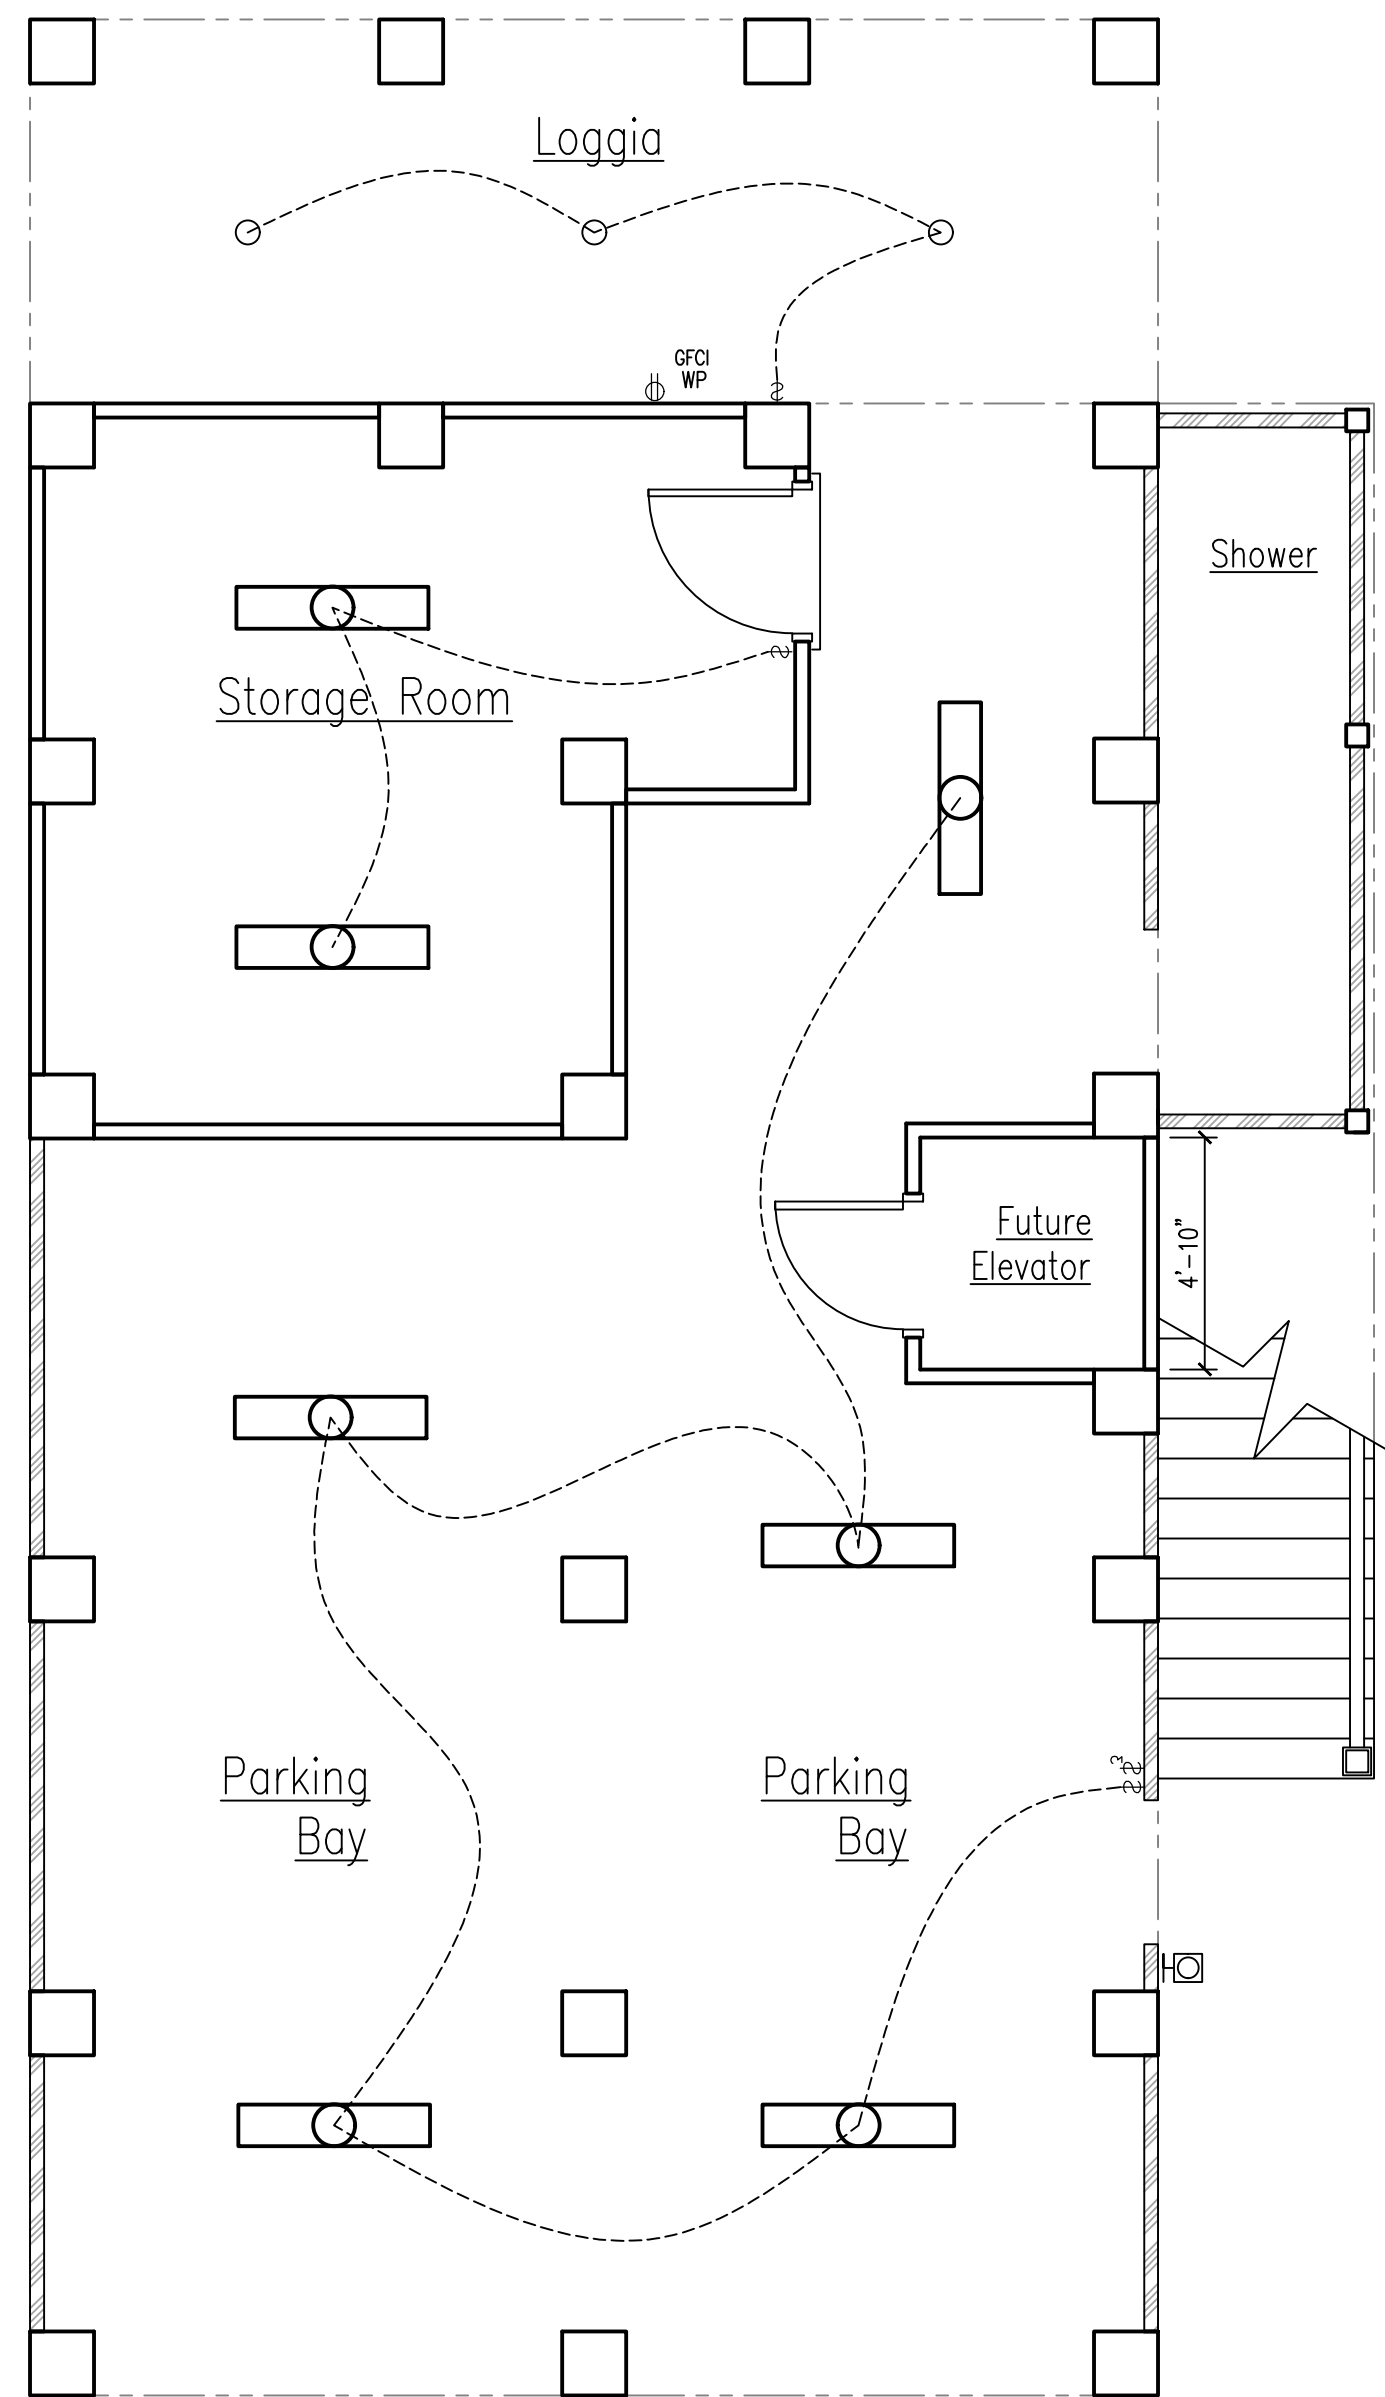

Ground Floor Electrical Plan

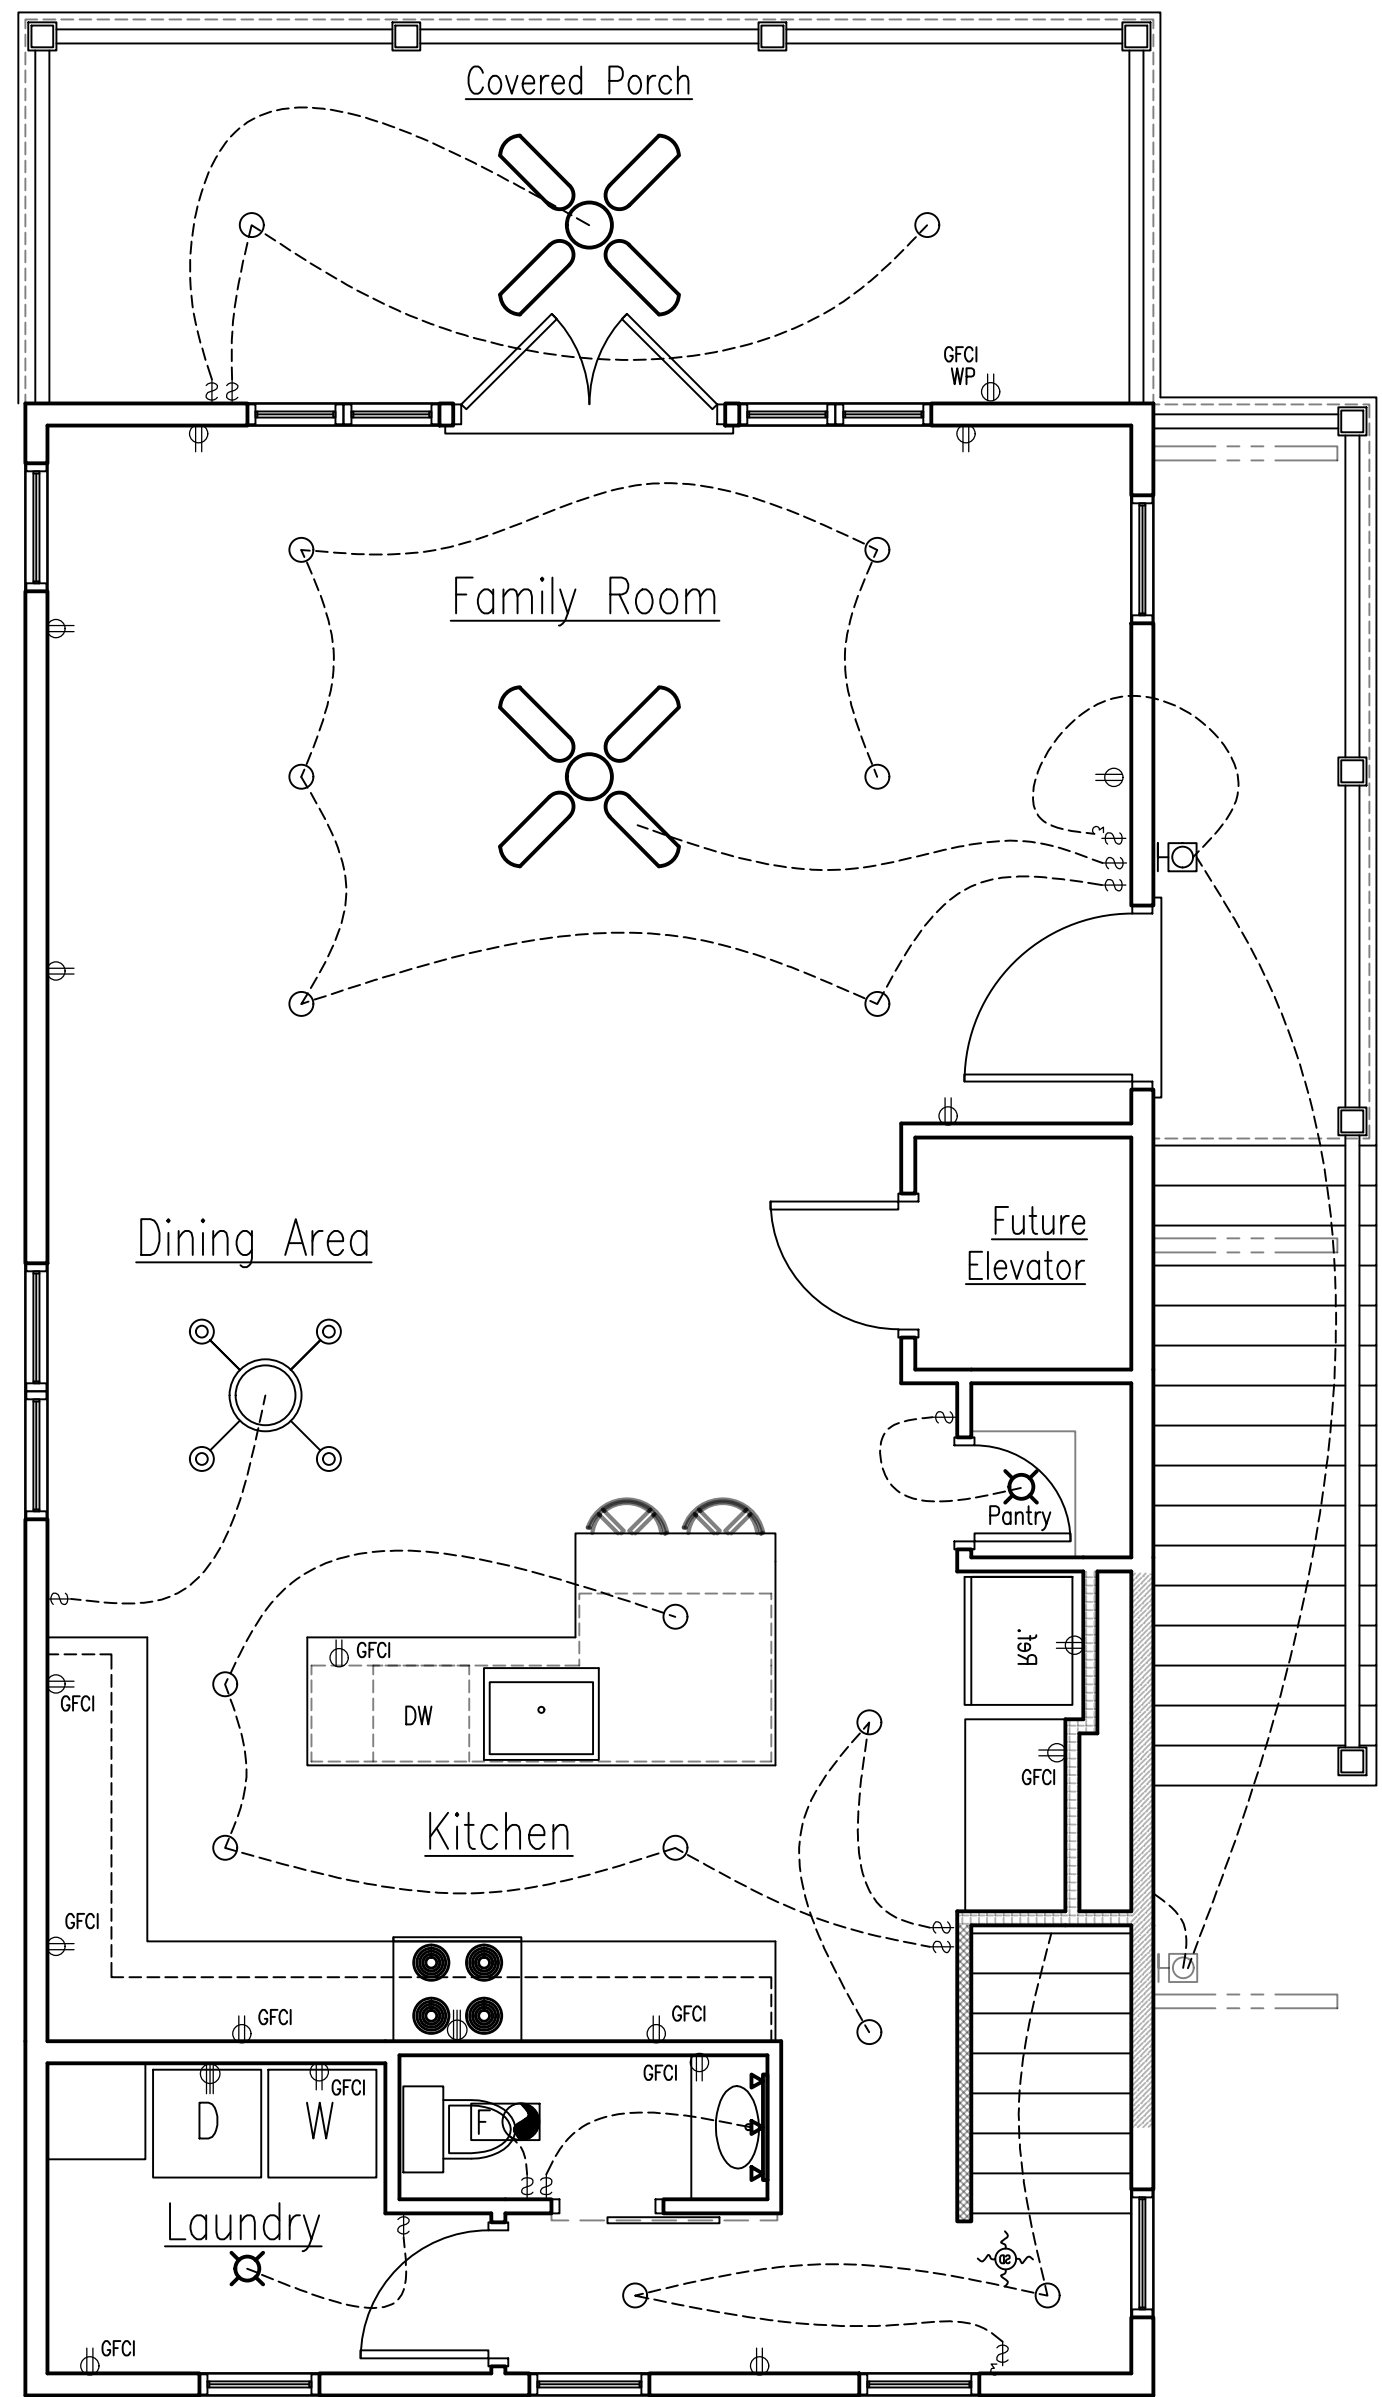

Main Floor Electrical Plan

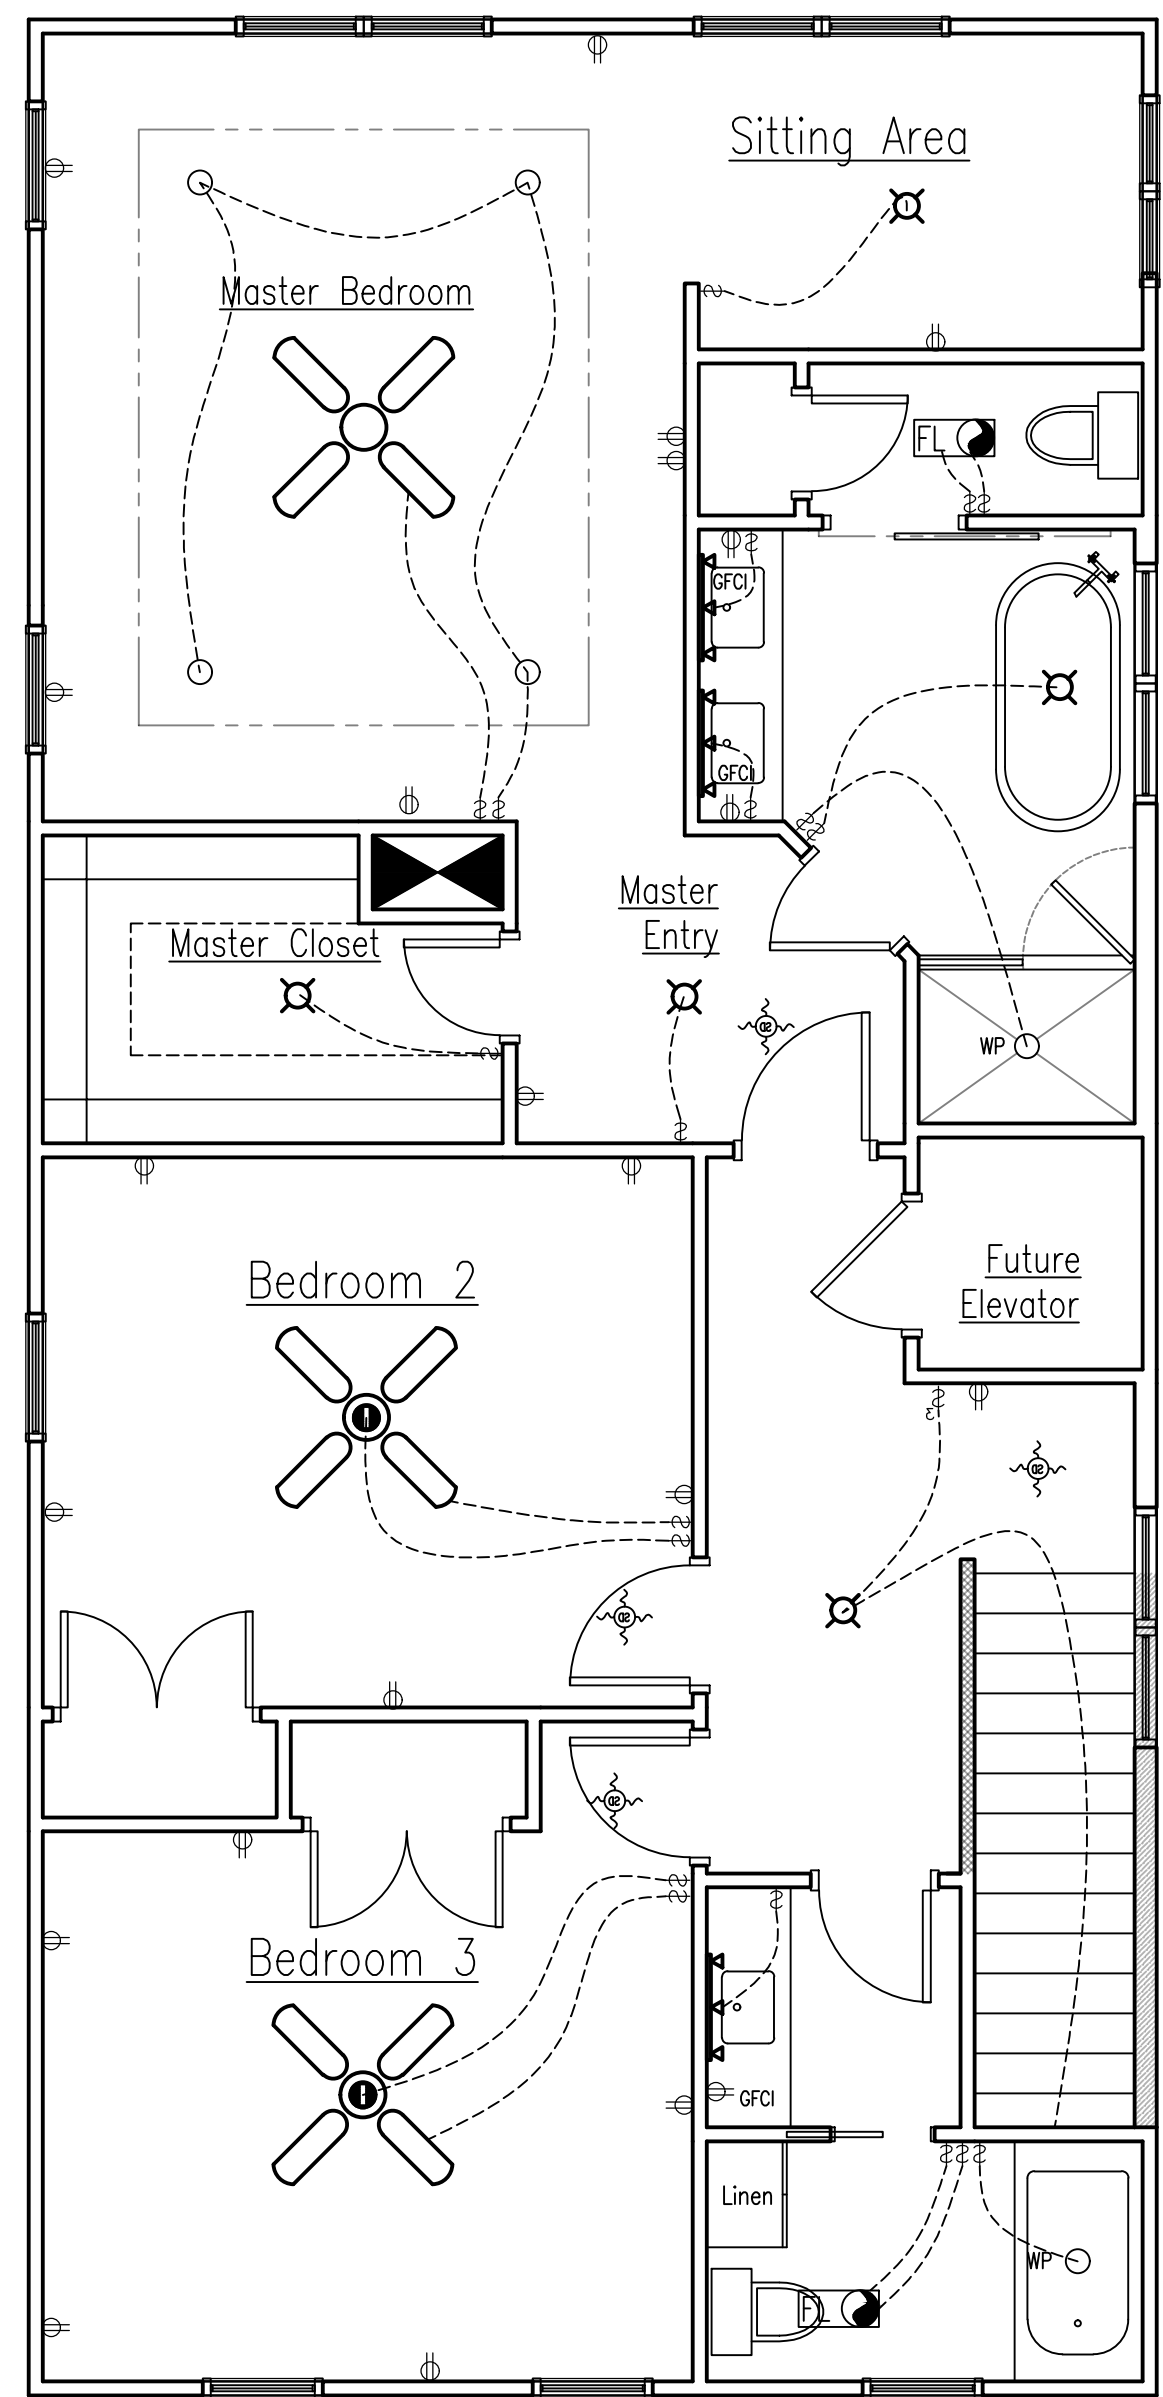

Upper Floor Electrical Plan

Legend			
	Pendant Light		Wall Switch
	Under Cabinet Lighting		3 Way Switch
	Ceiling Fan w/ Light		Duplex Receptacle
	4' Fluorescent Fixture		Ground Fault Circuit Interrupted
	Wall Mounted Vanity Fixture		Weather Proof
	Hanging Fixture		Verify Height
	Exhaust Fan/ Light		Exhaust Fan
	Ceiling Mounted Fixture		220V Receptacle
	Flood Light		Ethernet
	Weather Proof Recessed Light		Cable TV/ Outlet Combination
	Recessed Light		Electrical Service Panel
	Weather Proof 4" Recessed LED Light		Wall Mounted 12 Port Ethernet Patch Panel
			Hose Bib
			Junction Box for future fixture
			Sconce
			Smoke/CO Detector
			Propane Connection

CHAMBLISS RESIDENCE
LOT 31 MARSHLAND PARK
GEORGETOWN COUNTY, SC

DESIGNS
BY
DANIEL

1700 Airways Road, Suite 104
Myrtle Beach, SC 29577-2255

PROJECT REF.
Lot 31 MP

DRAWING STATUS/ DATE

☒ Estimating 8-14-18

☒ Construction 1-28-19

☒ Construction 11-24-20

DRAWING
Electrical Plan

Scale: 1/4" = 1'-0"

Page #

5